



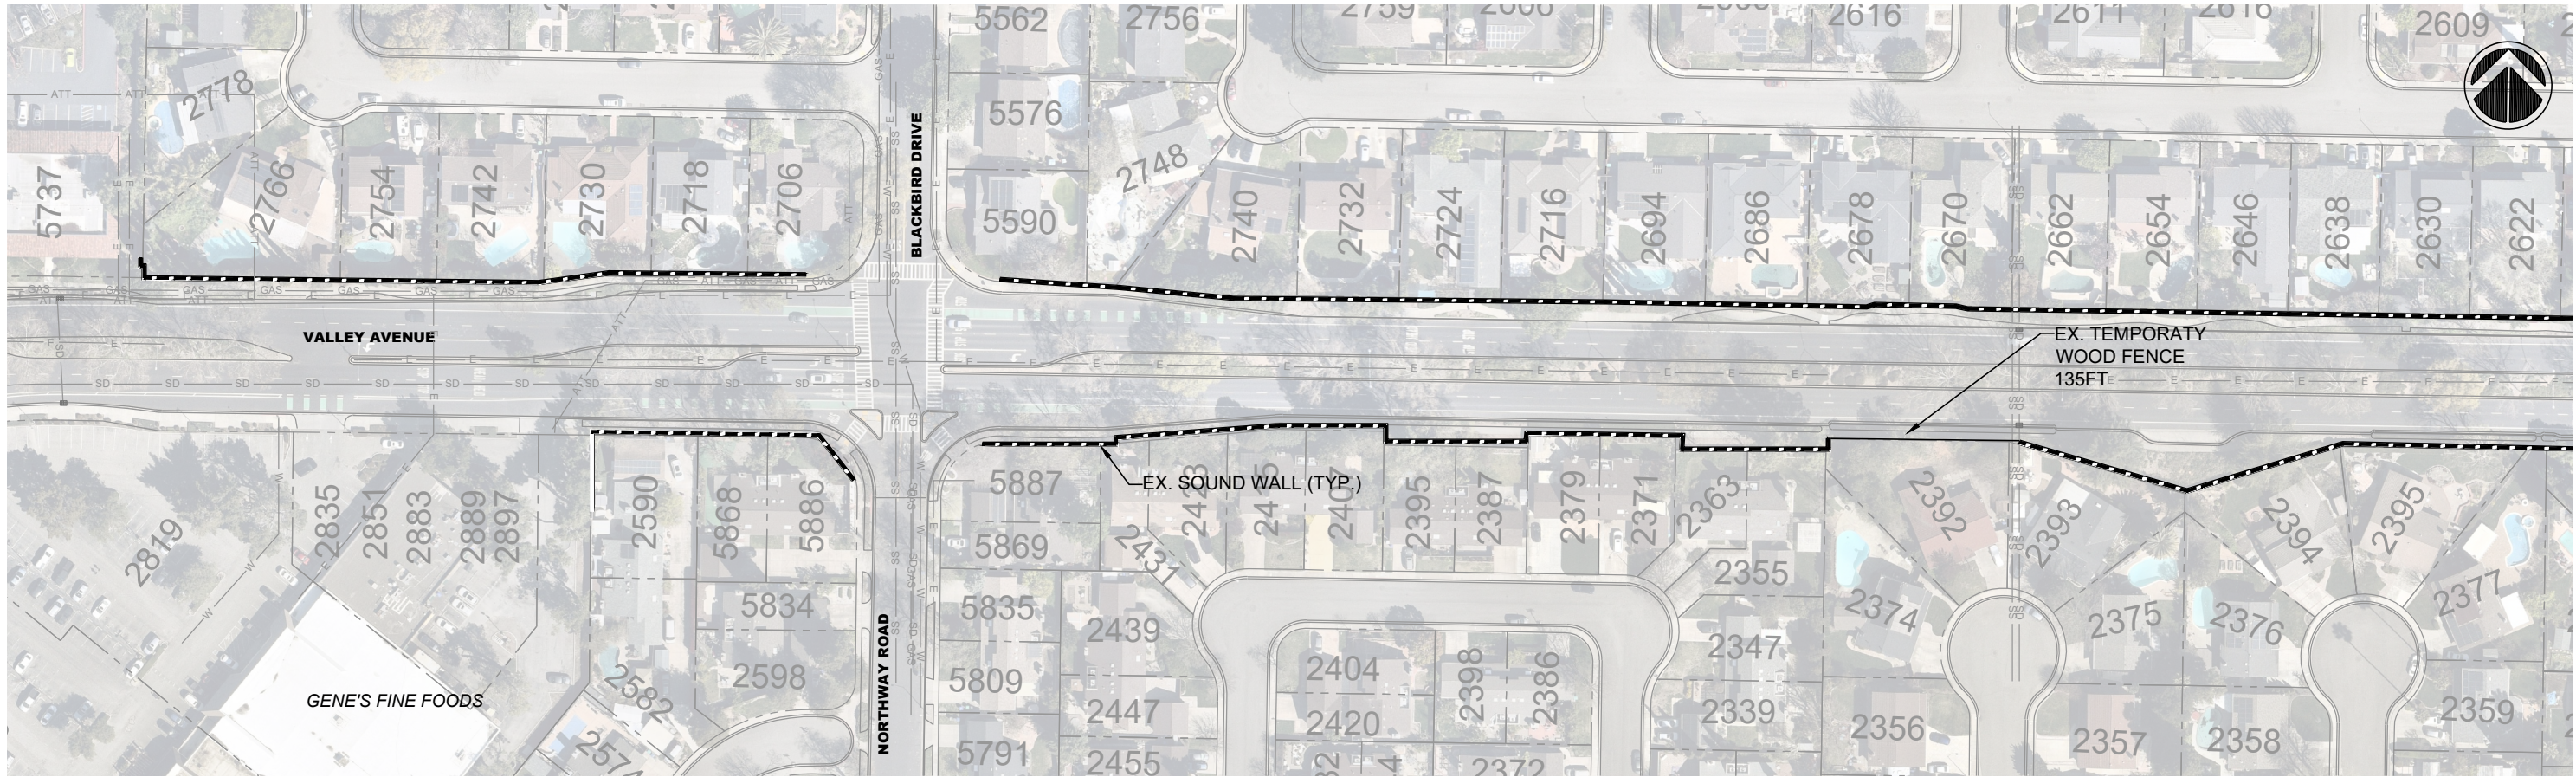


MATCHLINE SEE BOTTOM LEFT

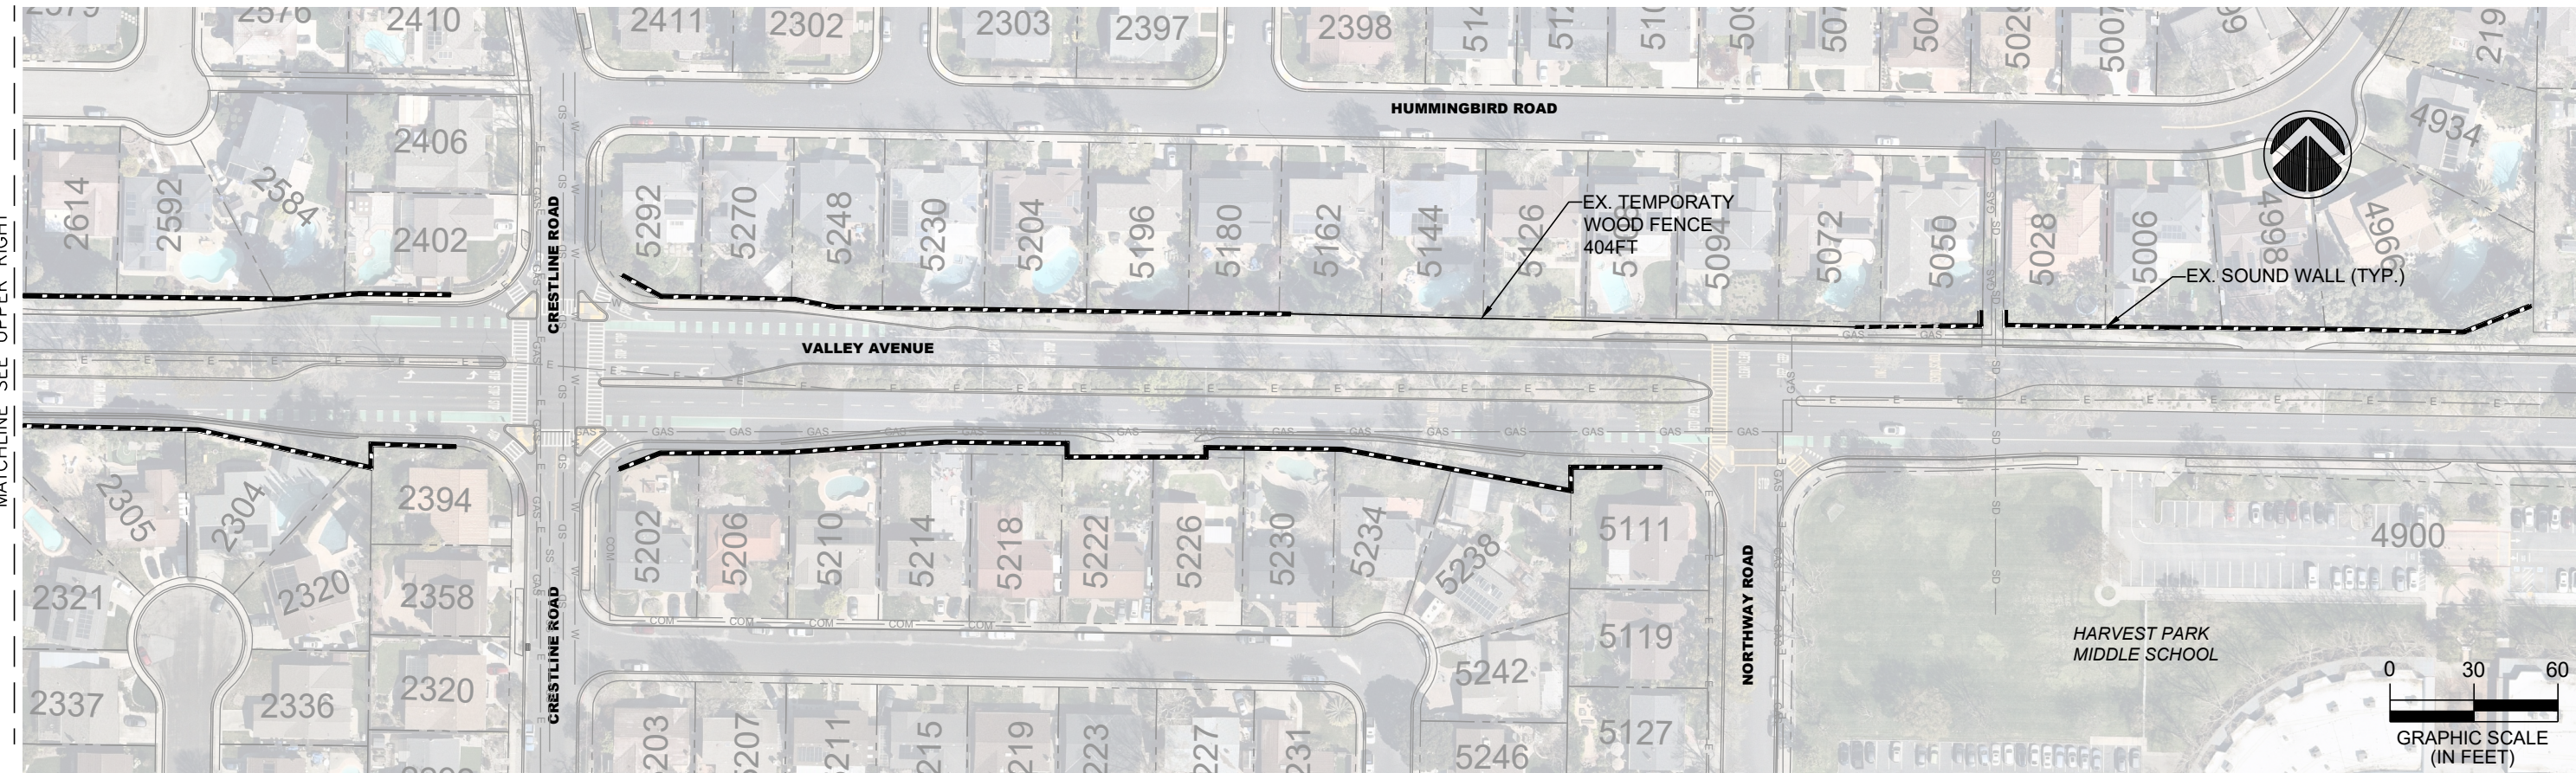

MATCHLINE SEE DRAWING C-2

MATCHLINE SEE UPPER RIGHT

REV.	DATE	DESCRIPTION

 


CITY OF PLEASANTON
PUBLIC WORKS DEPARTMENT

ADAM M. NELKIE
CITY ENGINEER
NO. 78830
EXP. 9/30/25

VALLEY AVENUE SOUND WALLS TEMPORARY REPAIR

UTILITY PLAN

DESIGN:	AN	SCALE:	AS SHOWN	DWG NO.
DRAWN:	SN	PROJECT NO.:	CIP-24416	C-1
CHECKED:	AN	DATE:	March 3, 2025	4 OF 8
TRAFFIC ENGINEER:	MT			

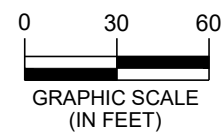

REV.	DATE	DESCRIPTION	 CITY OF PLEASANTON	CITY OF PLEASANTON PUBLIC WORKS DEPARTMENT	ADAM M. NELKIE CITY ENGINEER NO. 78830 EXP. 9/30/25	VALLEY AVENUE SOUND WALLS TEMPORARY REPAIR	DESIGN:	AN	SCALE:	AS SHOWN	DWG NO.		
									DRAWN:	SN	PROJECT NO.:	CIP-24416	C-2 5 OF 8
									CHECKED:	AN	DATE:	March 3, 2025	
									TRAFFIC ENGINEER:	MT			
UTILITY PLAN													